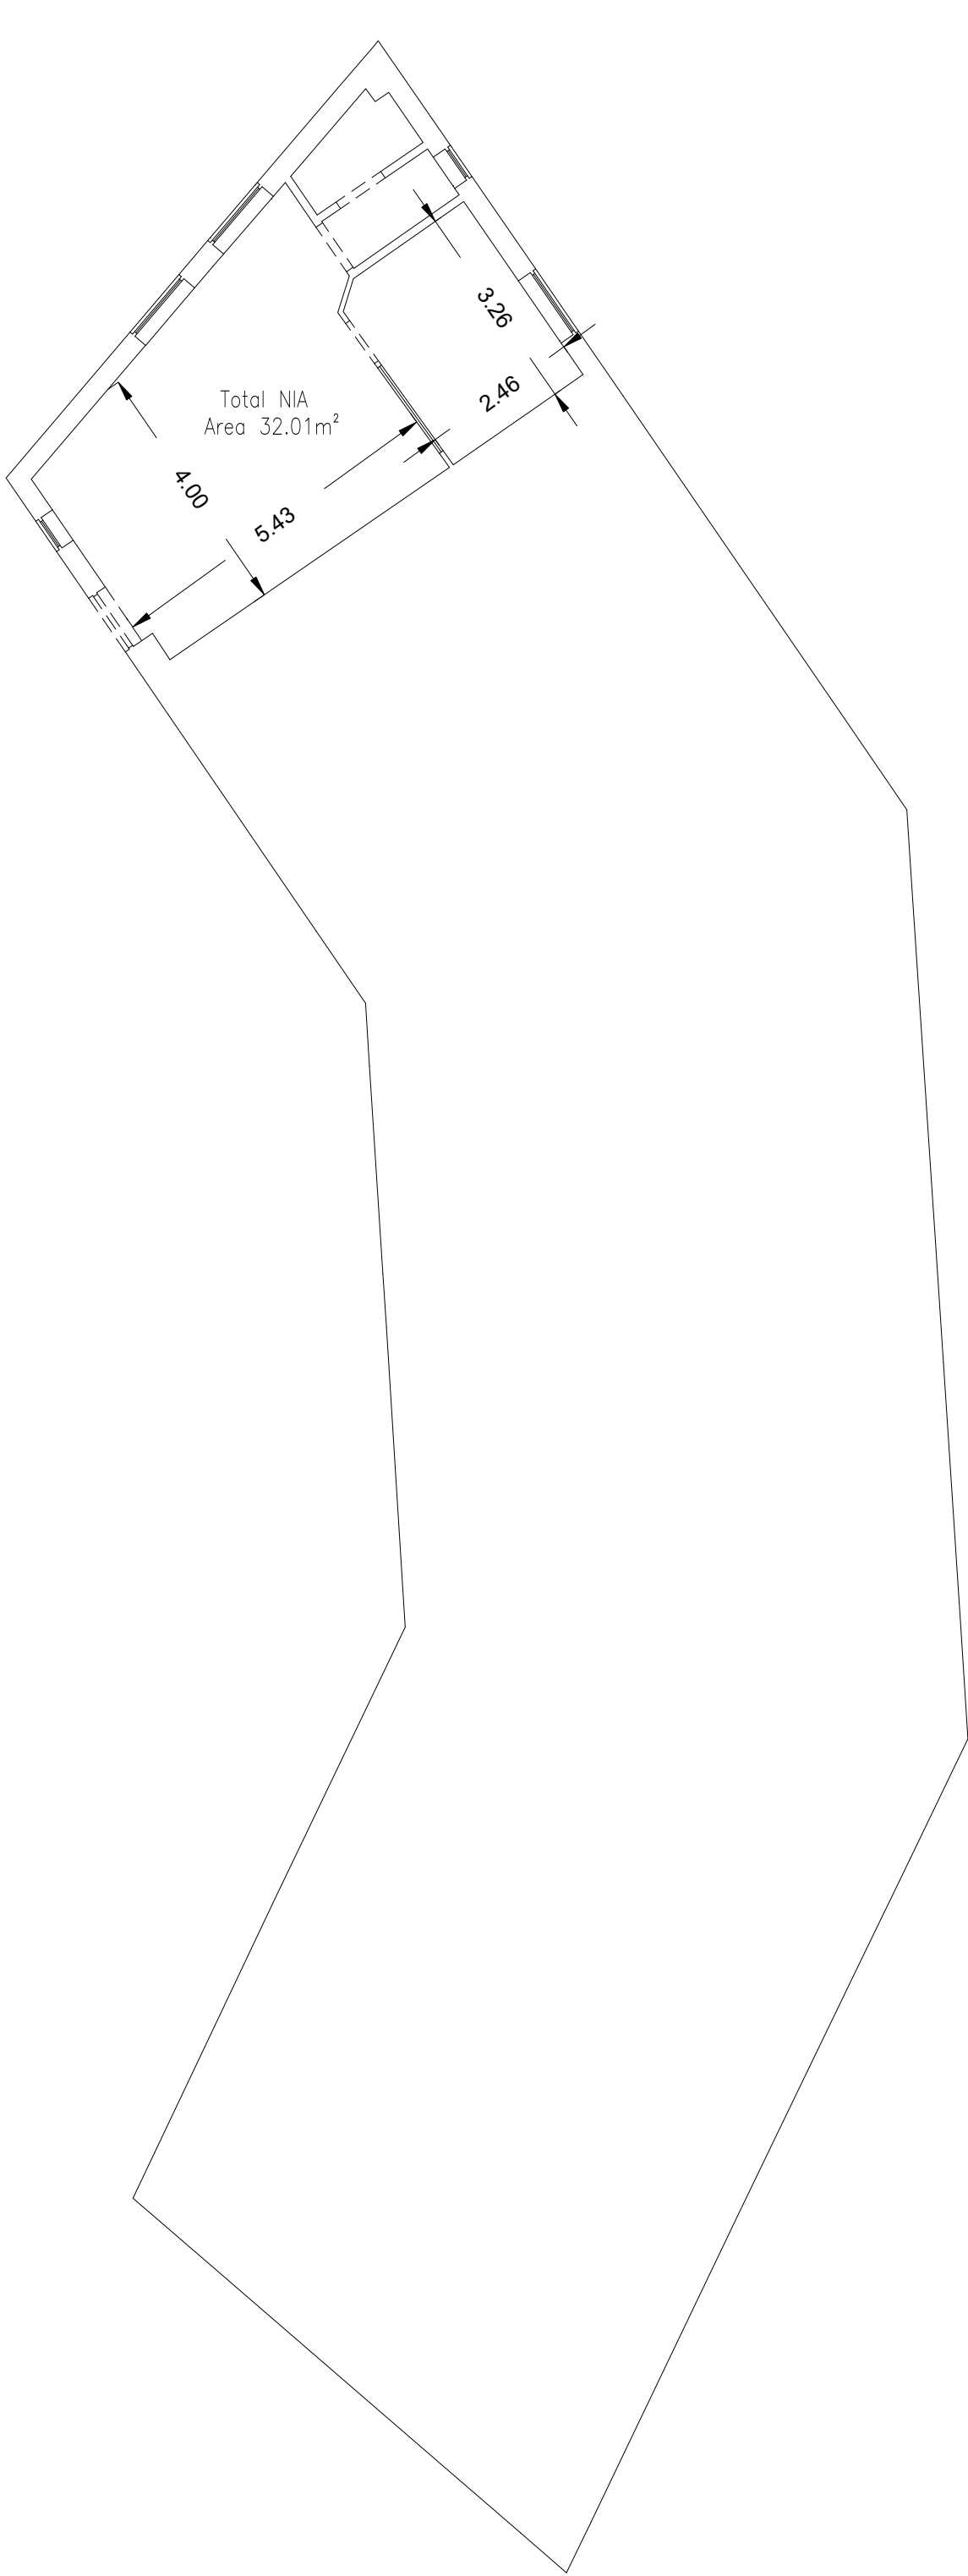


Legend:

Abbreviated Features:

AB Air Brick
B Balcony
C/B Close Boarded
C-H Cill to Head
C/L Chain Link
CL Ceiling Level
CPD Cupboard
CR Crown Point Level
DH Door Height
Dr Drain
FE Fire Exit
F-C Floor to Cill
FL Floor Level
FW Four Water
MH Manhole
G Gully
IC Inspection Chamber
IL Invert Level
I/R Iron Railings

LI Light
D/F Overflow Pipe
P Post
P/C Pitched Ceiling
PE Pipe
P/R Pitched Roof
P/W Post & Wire
RD Roller Door
RNP Rainwater Pipe
SD Sliding Doors
SSL Suspended Ceiling Level
SP Spring Point Level
SVP Soil & Vent Pipe
SW Surface Water
US Underside
UTL Unstable To Lift
VP Vent Pipe
VI Vent

Radiator
Light
Emergency Light
Strip Light
Wall Mounted Light
Mains Point
Blank Plate
Light Switch
Pendant Switch
Isolator Switch
Alarm Bell
Fire Alarm Push
Smoke Detector
Alarm Panel
Thermostat
Modern
Fuse Box
Electric Box
Heater
Water Stop Tap
Overhead Features

Plan Coordinate Control:--
N/A

Level Datum:--
All Levels relate to OSGB36 using GPS

Key:

Notes:

REV A Areas & Dimensions added 07/03/25 S.J.H

REV NO REV NOTE DATE SIGNED

3 Brookfield, Duncan Close,
Moulton Park, Northampton, NN3 6WL
Tel: 01604 491543
Email: info@globalsurveys.co.uk

Site: Warren Park
Wolverton
Milton Keynes MK12 5NF

Client: Milton Keynes Parks Trust

Survey Title: Measured Building Survey
14 Canon Harnett Court Floor Plans

Date February 2025
Dwg No. 24708_14_CHC
Sheet 1 of 1

Scale 1/100
Surveyor KMG
Checked S.J.H