
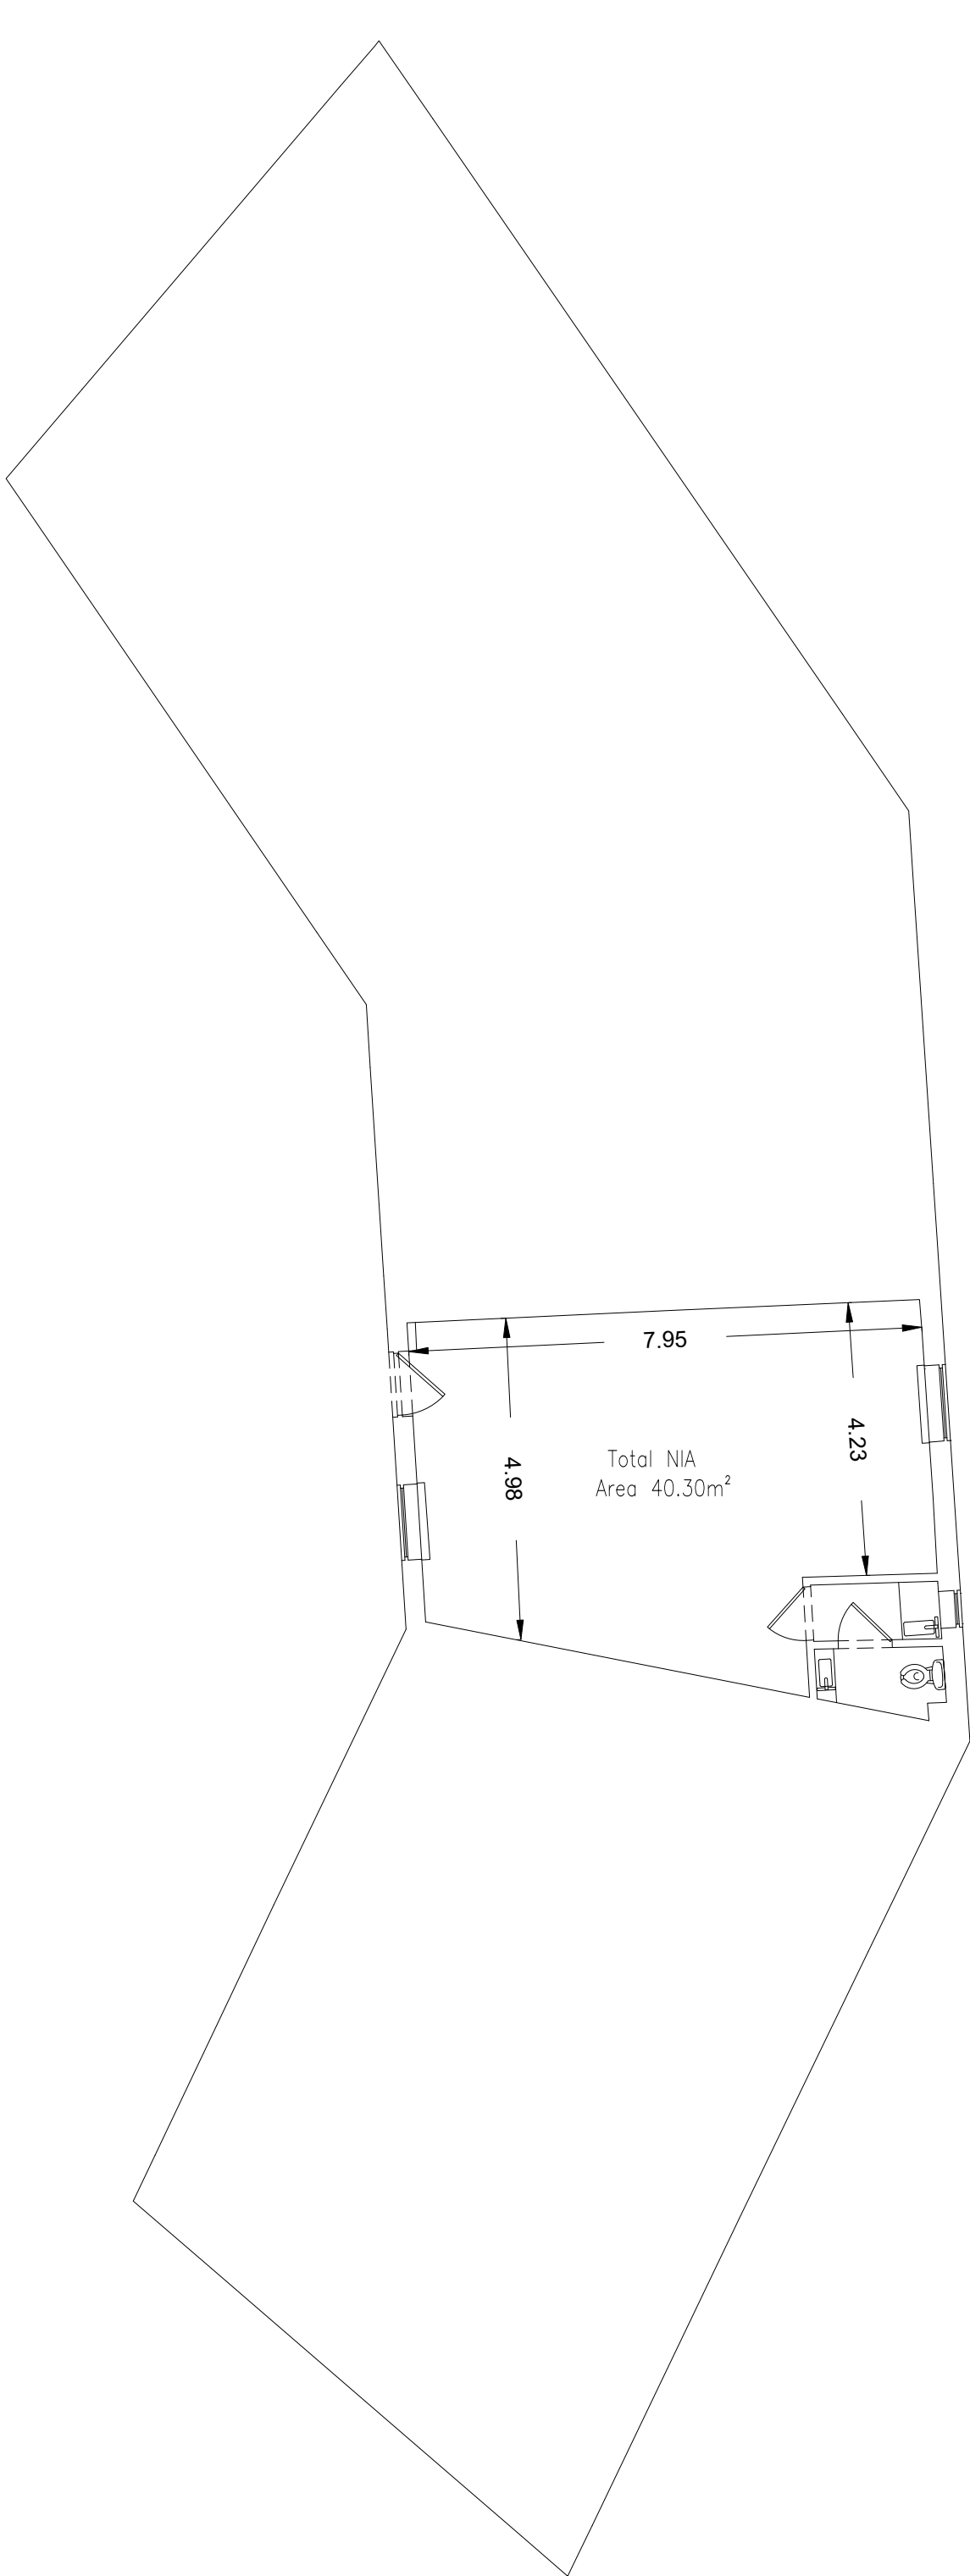



Legend:			
Abbreviated Features:	Symbols:		
AB Air Brick	LI Light	Radiator	RA
B Ballard	D/F Overflow Pipe	Light	⊗
C/B Close Boarded	P Post	Emergency Light	⊗
C-H Cill to Head	P/C Pitched Ceiling	Strip Light	—
C/L Chain Link	PS Pipe	Wall Mounted Light	—
CL Ceiling Level	P/R Pitched Roof	Mains Point	^
CPD Cupboard	P/W Post & Wire	Blank Plate	^
CR Crown Point Level	RD Roller Door	Light Switch	^
DH Door Height	RNP Bonewater Pipe	Pendant Switch	^
Dr Drain	SD Sliding Doors	Isolator Switch	^
FE Fire Exit	SSL Suspended Ceiling Level	Alarm Bell	AB
F-C Floor to Cill	SP Spring Point Level	Fire Alarm Push	FA
FL Floor Level	SW Soil & Vent Pipe	Snow Detector	SD
FW Four Water	SW Surface Water	Alarm Panel	AP
M Manhole	US Underside	Thermotast	TR
U Dully	UTL Underside To Lift	Modern	TR
I Inspection Chamber	VP Vent Pipe	Fuse Box	FB
IR Iron Railings	VI Vent	Electric Box	EB
		Heater	HT
		Water Stop Tap	WST
		Overhead Features	-----

Plan Coordinate Control:--
N/A
Level Datum:--
All Levels relate to OSGB36 using GPS

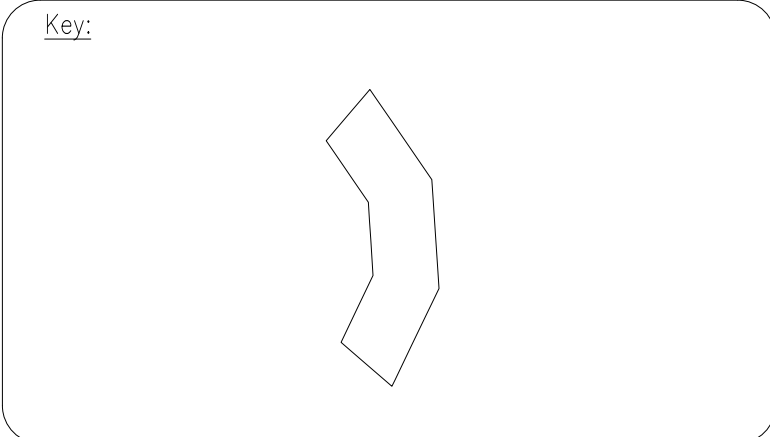

Notes:

REV A	Areas & Dimensions added	07/03/25	SJH
REV NO	REV NOTE	DATE	SIGNED

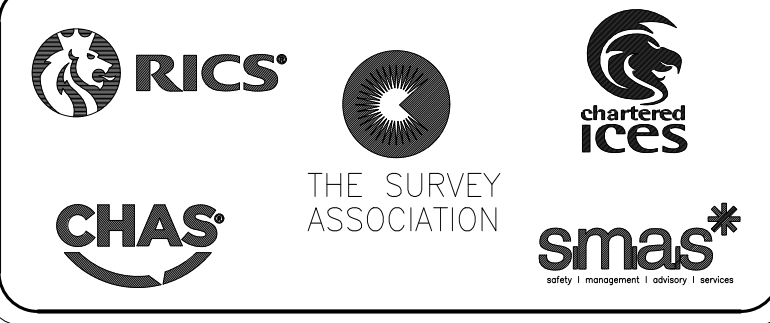

GLOBAL SURVEYS

3 Brookfield, Duncan Close,
Moulton Park, Northampton, NN3 6WL
Tel: 01604 491543
Email: info@globalsurveys.co.uk

Site:	Warren Park Wolverton Milton Keynes MK12 5NF
Client:	Milton Keynes Parks Trust
Survey Title:	Measured Building Survey 17 Canon Harnett Court Floor Plans

Date	February 2025	Scale	1/100 @ A1
Dwg No.	24708_17_CHC	Surveyor	KMG
Sheet	1 of 1	Checked	SJH