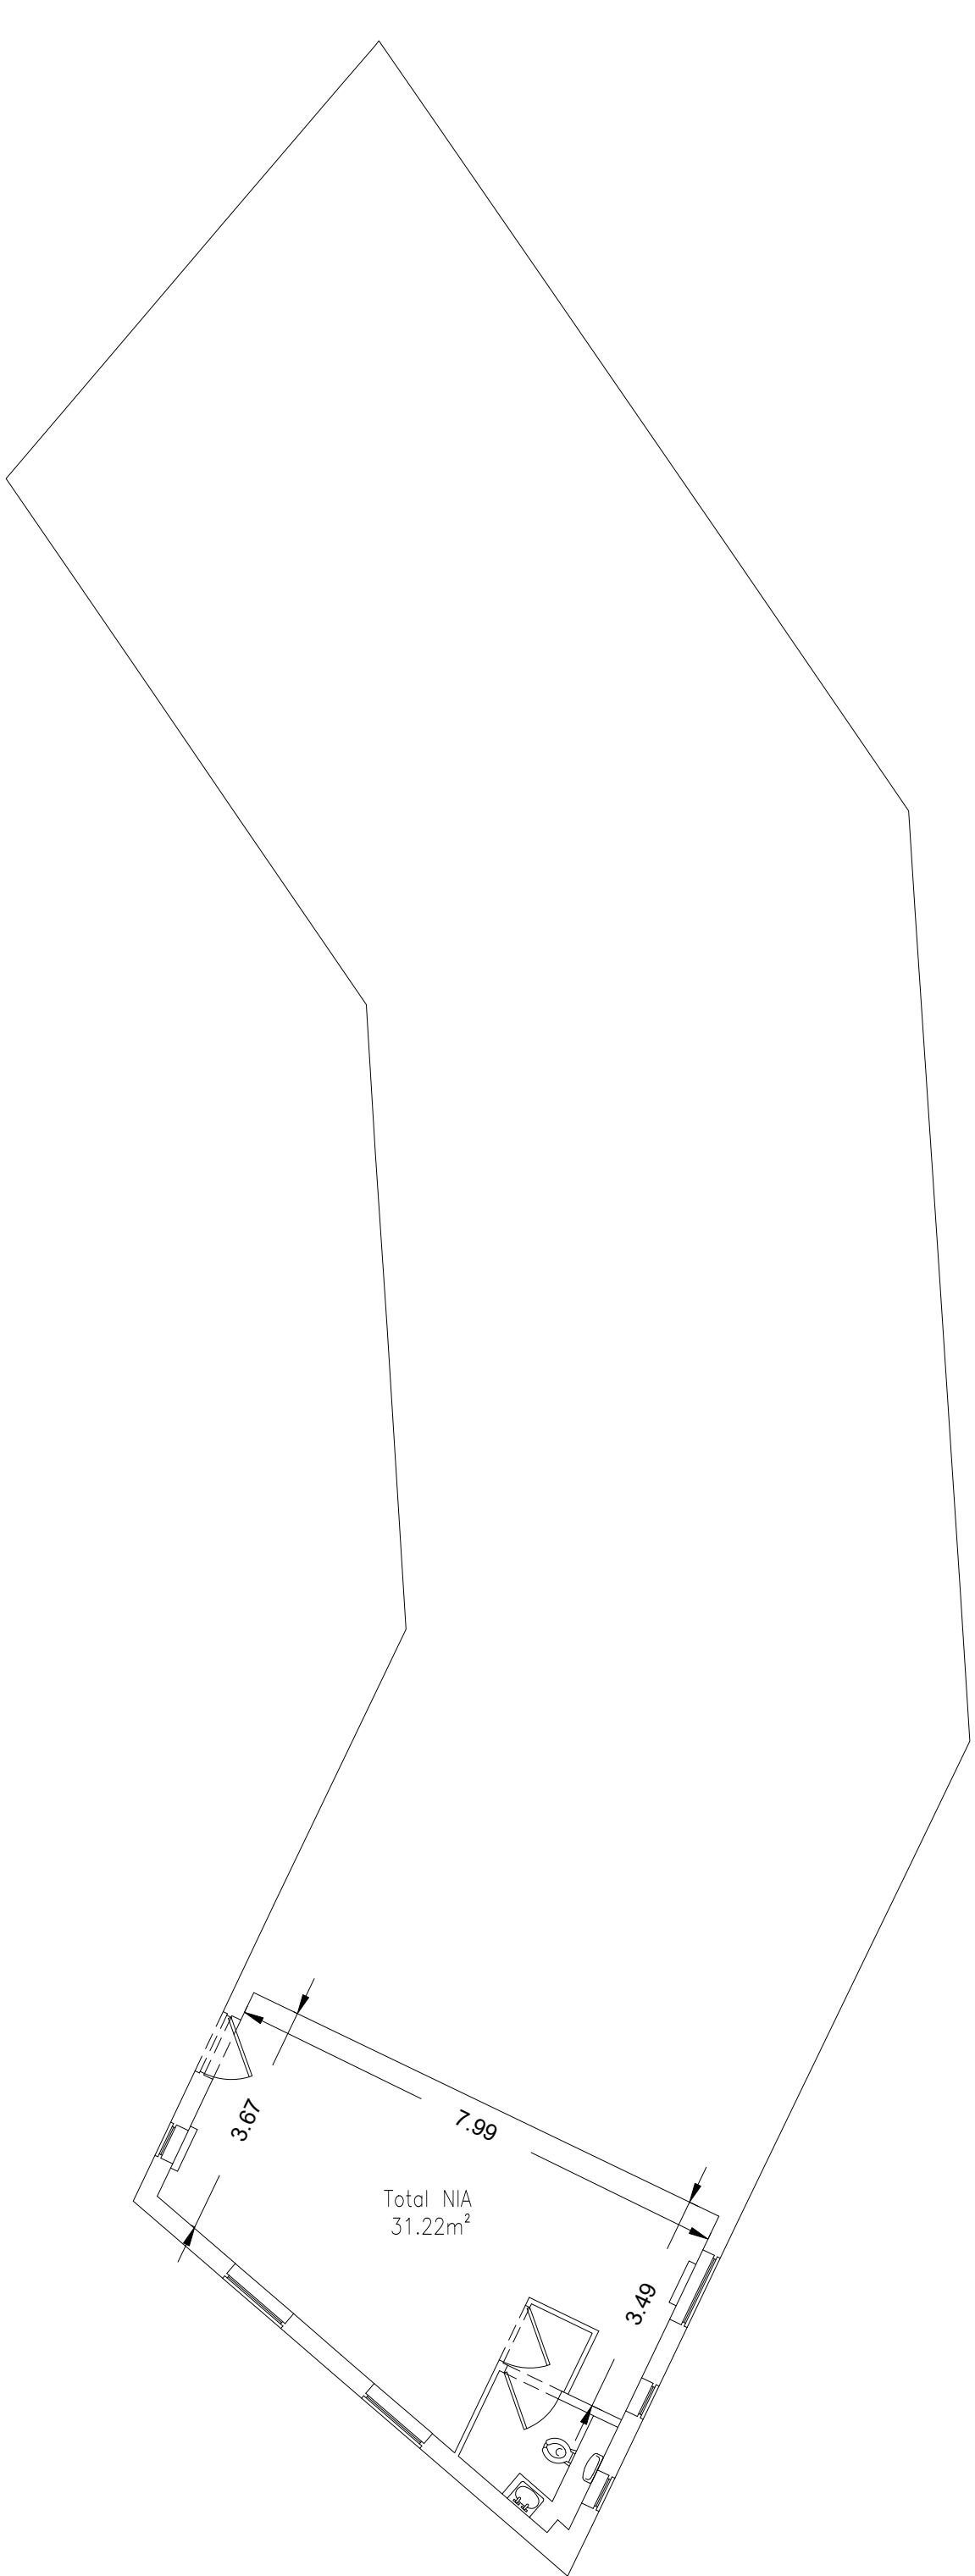


Legend:

Abbreviated Features:

AB

Air Brick

B

Bolard

C/B

Cone Bordered

C-H

Cil to Head

C/L

Chain Link

CL

Ceiling Level

CPD

Cupboard

CR

Crown Point Level

DH

Door Height

Dr

Drain

FE

Fire Exit

F-C

Floor to Cill

FL

Floor Level

FW

Foul Water

MH

Manhole

U

Dully

C

Inspection Chamber

IL

Invert Level

I/R

Iron Railings

LI

Light

D/F

Overflow Pipe

P

Post

P/C

Pitched Ceiling

PE

Pipe

P/R

Pitched Roof

P/W

Point & Wire

RD

Roller Door

RE

Rodding Eye

RNP

Rainwater Pipe

SD

Sliding Doors

SSL

Suspended Ceiling Level

SP

Spring Point Level

SUP

Soil & Vent Pipe

SW

Surface Water

US

Understore

UTL

Unstable To Lift

VP

Vent Pipe

VI

Vent

Radiator

Light

Emergency Light

Strip Light

Wall Mounted Light

Mains Point

Blank Plate

Light Switch

Pendant Switch

Isolator Switch

Alarm Bell

Alarm Switch

Fire Alarm Push

Snow Detector

Alarm Panel

Alarm Panel

Thermotat

Thermotat

Modern

Fuse Box

Electric Box

Heater

Water Stop Tap

Overhead Features

Plan Coordinate Control:-

N/A

Level Datum:-

All Levels relate to OSGB36 using GPS

Key:

Notes:

REV A

Areas & Dimensions added

07/03/25

SJH

REV NO

REV NOTE

DATE

SIGNED

3 Brookfield, Duncan Close,
Moulton Park, Northampton, NN3 6WL
Tel: 01604 491543
Email: info@globalsurveys.co.uk

Site:

Warren Park
Wolverton
Milton Keynes MK12 5NF

Client:

Milton Keynes Parks Trust

Survey Title:

Measured Building Survey
13 Canon Harnett Court Floor Plans

Date

February 2025

Scale

1/100 @ A1

Dwg No.

24708_13_CHC

Surveyor

KMG

Sheet

1 of 1

Checked

SJH