

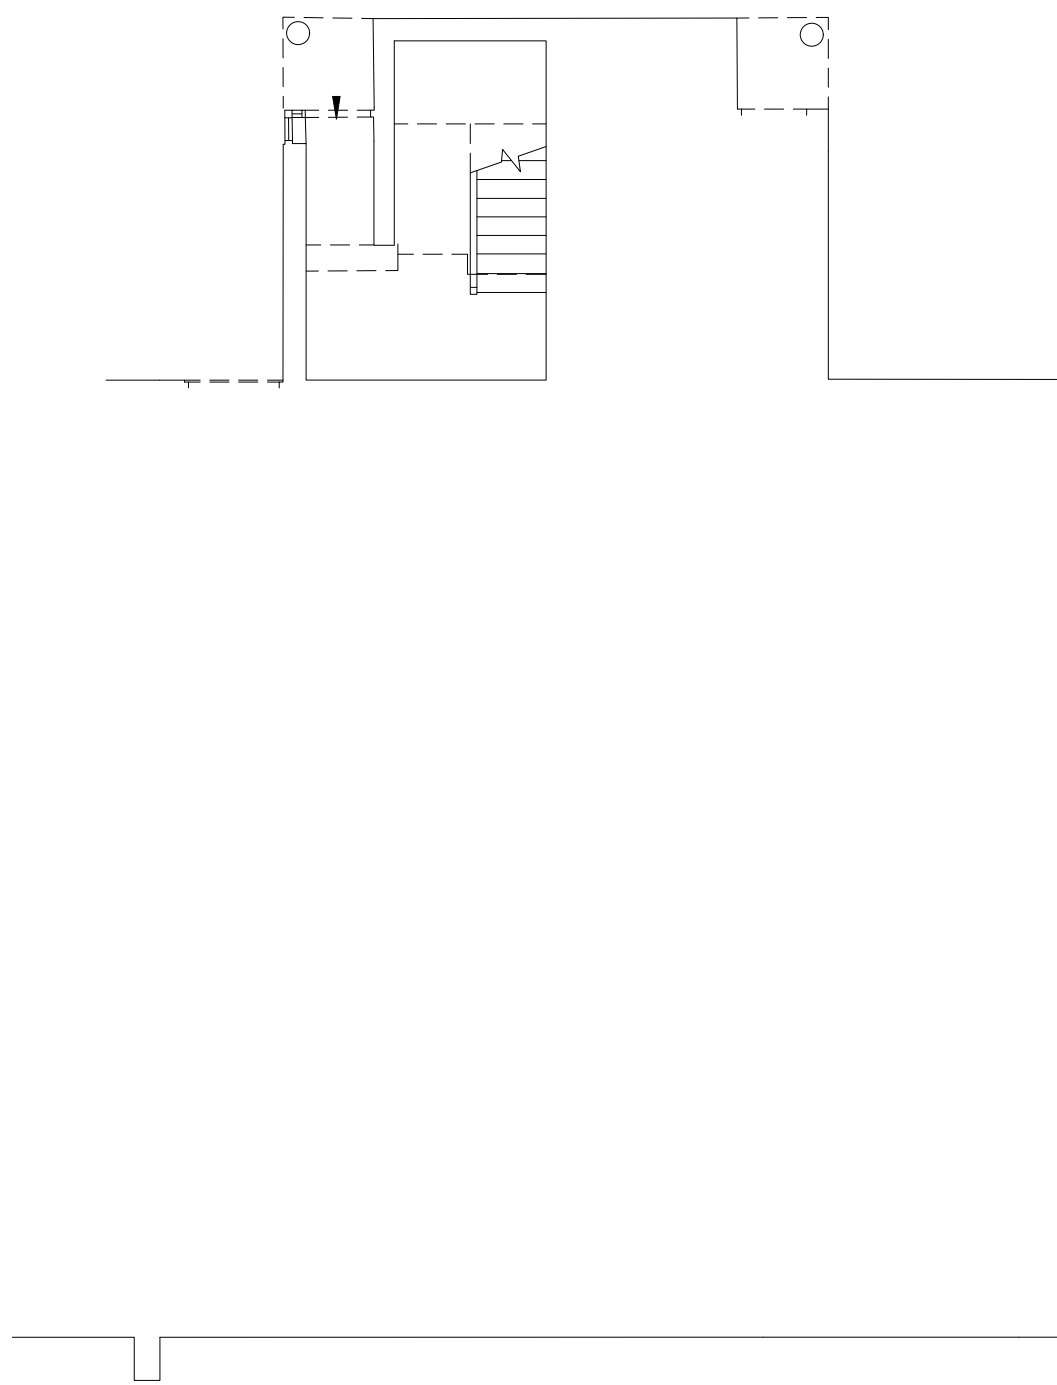


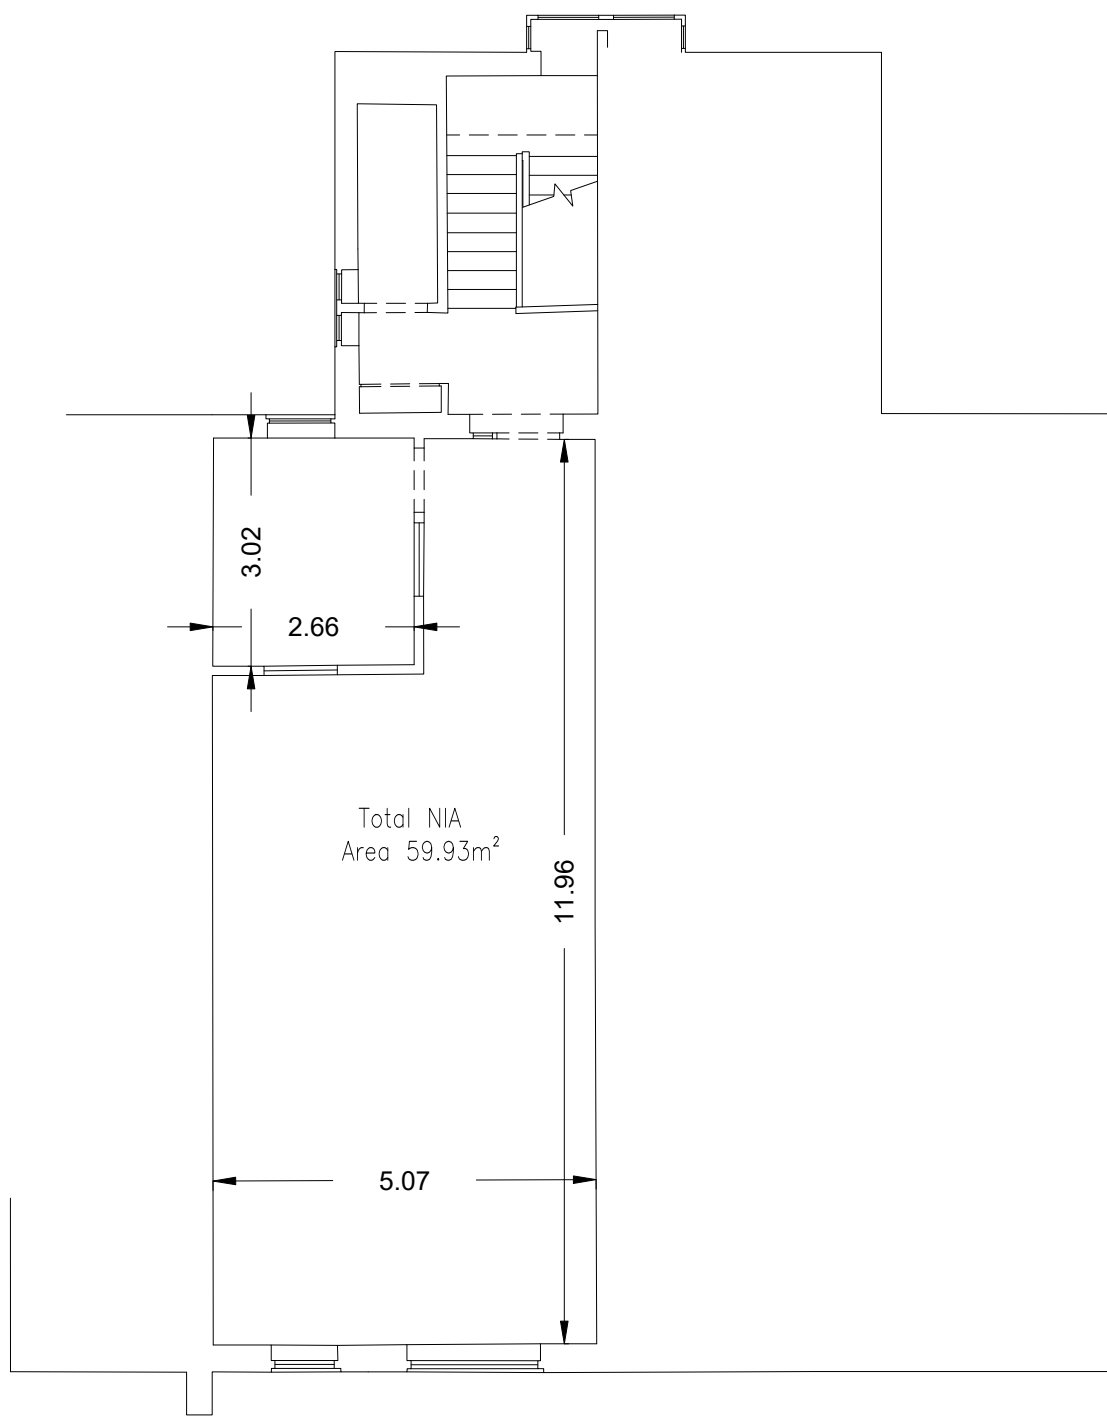

GROUND FLOOR PLAN

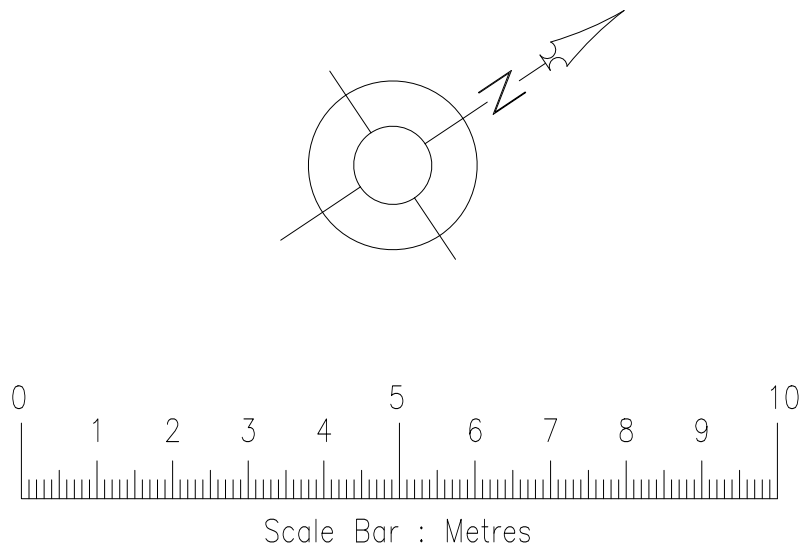

FIRST FLOOR PLAN

Legend:		
Abbreviated Features:	Symbols:	
AB Air Brick	LI Light	Radiator
B Balcony	D/F Overflow Pipe	Light
C/B Close Boarded	P Post	Emergency Light
C-H Cill to Head	P/C Pitched Ceiling	Strip Light
C/L Chain Link	PS Pipe	Wall Mounted Light
CL Ceiling Level	P/R Pitched Roof	Mains Point
CPD Cupboard	P/W Pitch & Wire	Blank Plate
CR Crown Point Level	RD Roller Door	Light Switch
DH Door Height	R/R Radiator Pipe	Pendant Switch
Dr Drain	SD Sliding Doors	Isolator Switch
FE Fire Exit	SQL Suspended Ceiling Level	Alarm Bell
F-C Floor to Cill	SP Spring Point Level	Fire Alarm Push
FL Floor Level	SW Surface Water	Snow Detector
FW Four Water	US Underside	Alarm Panel
MH Manhole	UTL Unable To Lift	Thermostat
G Gully	VP Vent Pipe	Modern
IC Inspection Chamber	VI Vent	Fuse Box
IL Invert Level		Electric Box
I/R Iron Railings		Heater
		Water Stop Tap
		Overhead Features -----

Plan Coordinate Control:-
N/A
Level Datum:-
All Levels relate to OSGB36 using GPS

Key:

Notes:

B	Areas & room dimensions added	07/03/25	SJH
A	Units on separate sheets	03/03/25	KMG
V NO REV NOTE		DATE	SIGNED

3 Brookfield, Duncan Close,
Moulton Park, Northampton, NN3 6WL
Tel: 01604 491543
Email: info@globalsurveys.co.uk

Site: Drakes Mews
Crownhill
Milton Keynes, MK8 0ER

Client: Milton Keynes Parks Trust

Survey Title: Measured Building Survey
Unit 6 Ground & First Floor Plans

Date	February 2025	Scale	1/100 @ A1
Dwg No.	24709-MBS-A	Surveyor	SPH
Sheet	1 of 2	Checked	SJH